
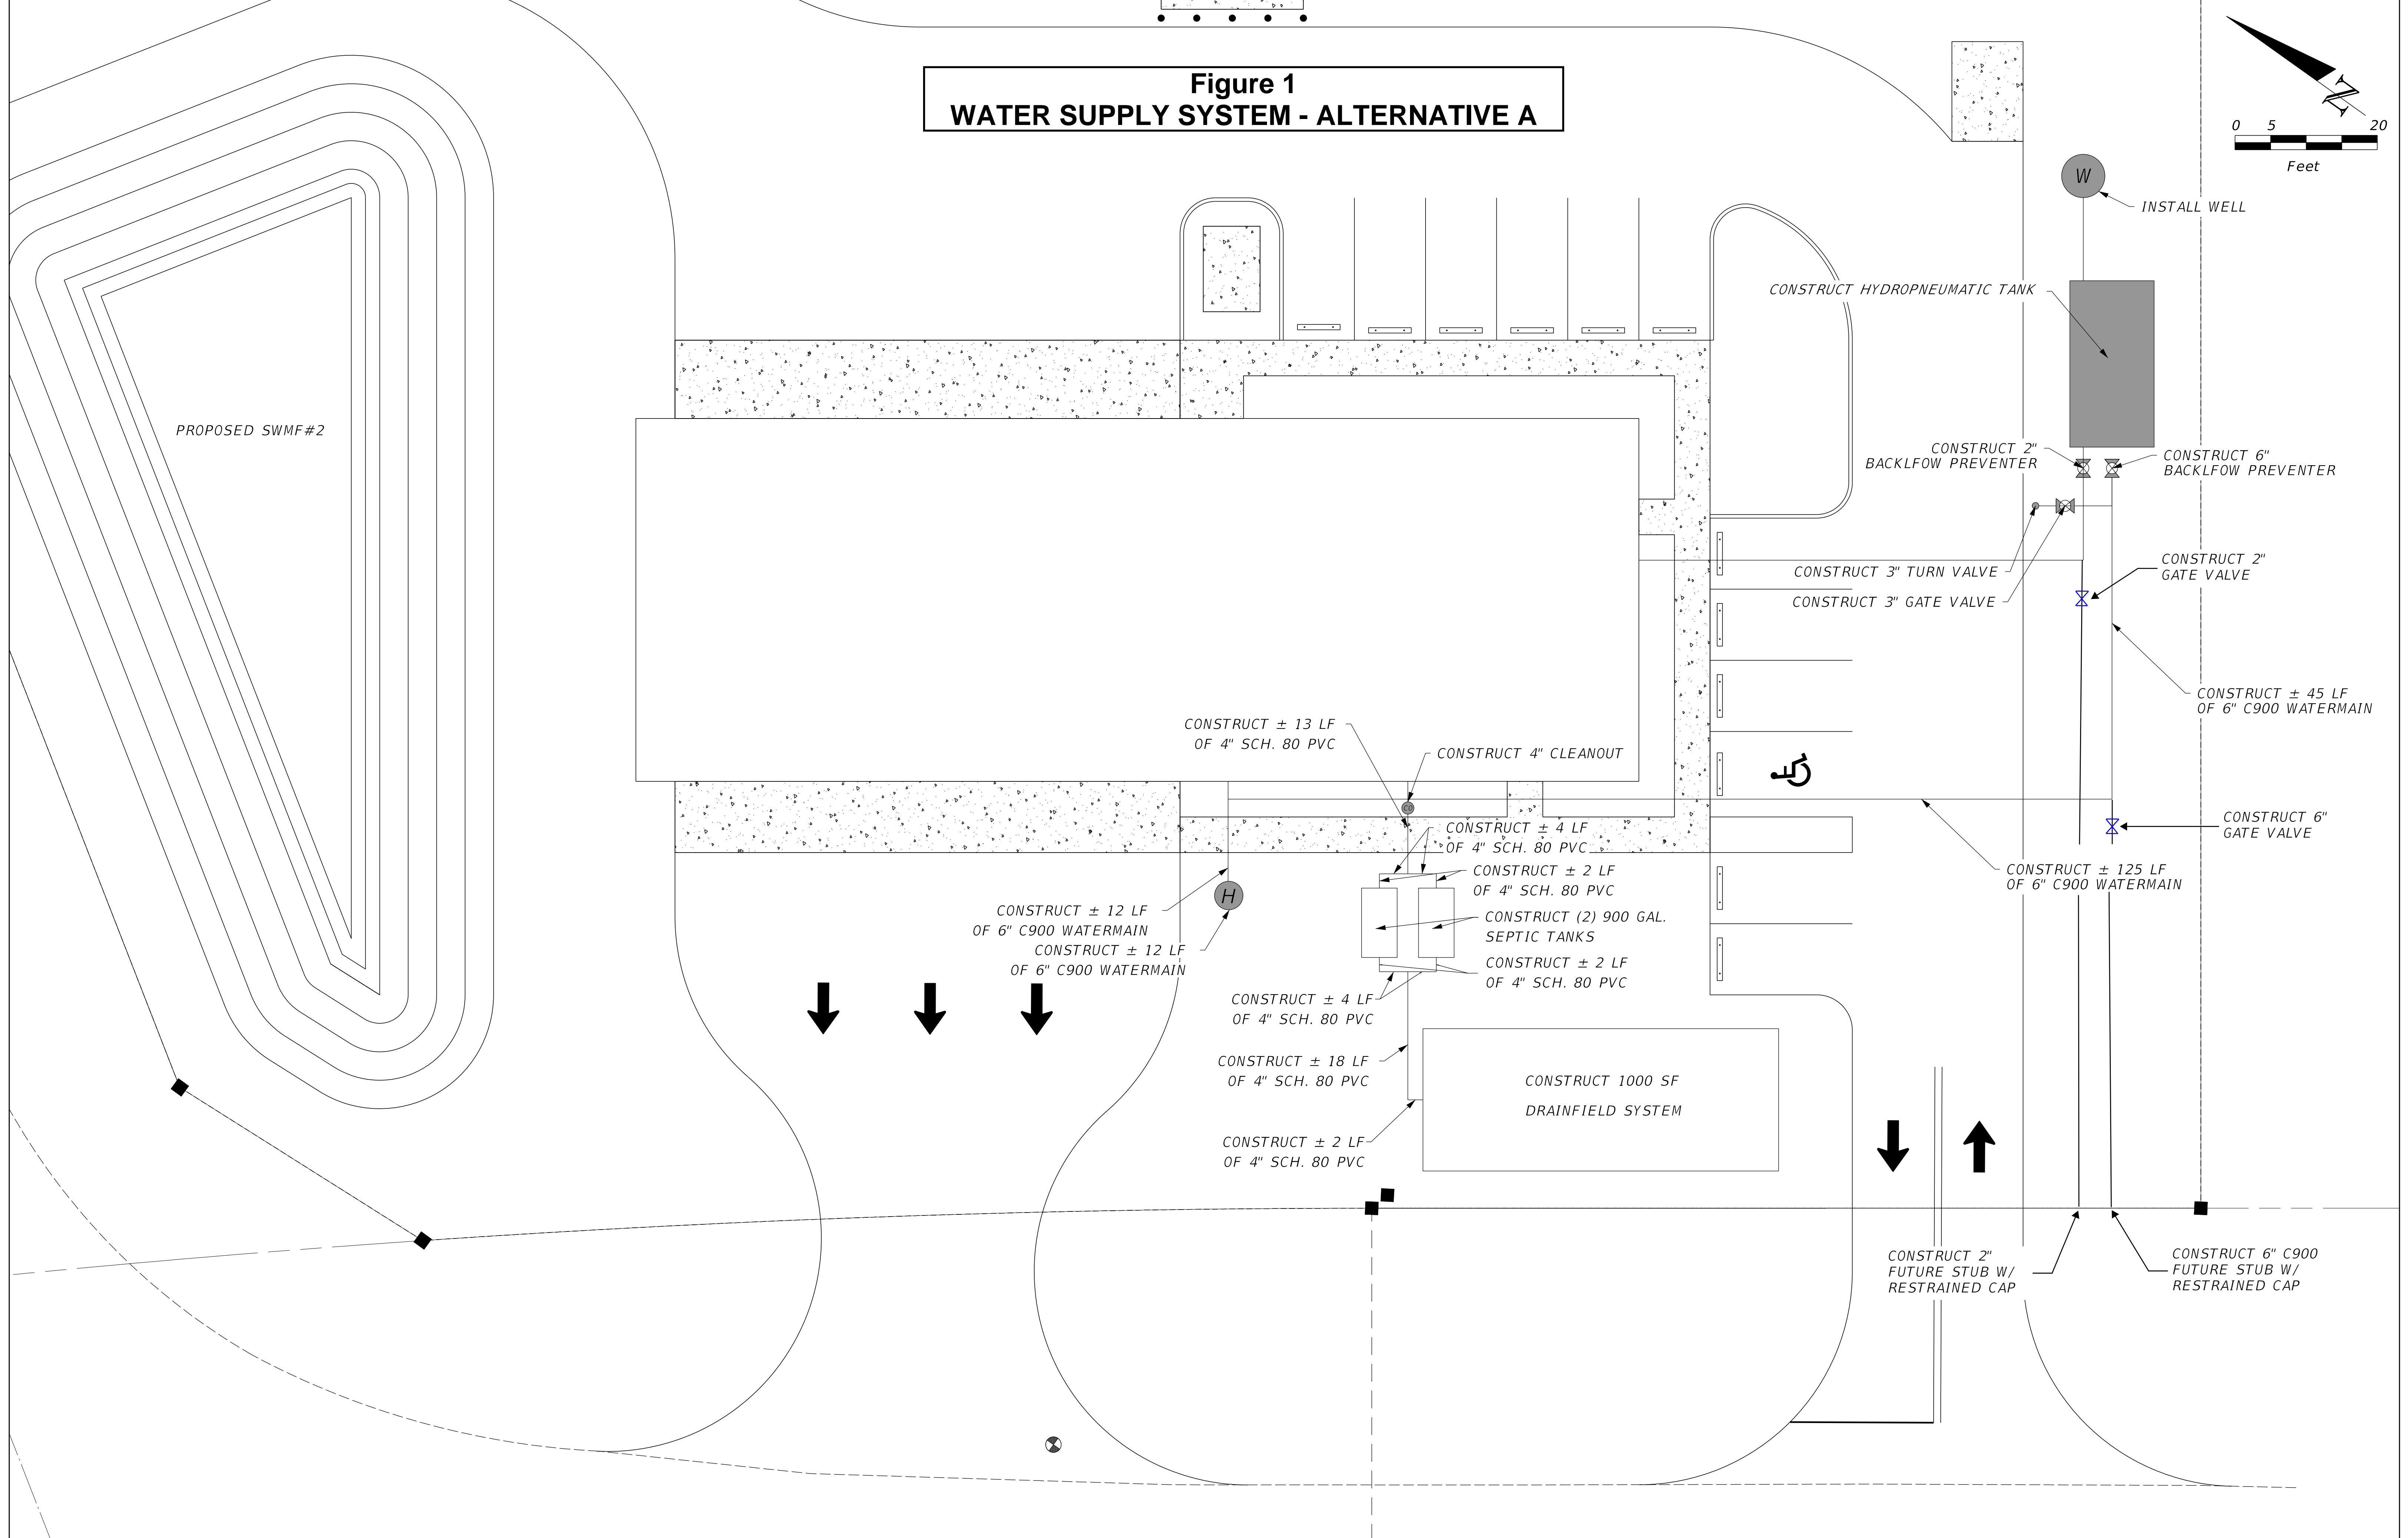


Figure 1
WATER SUPPLY SYSTEM - ALTERNATIVE A

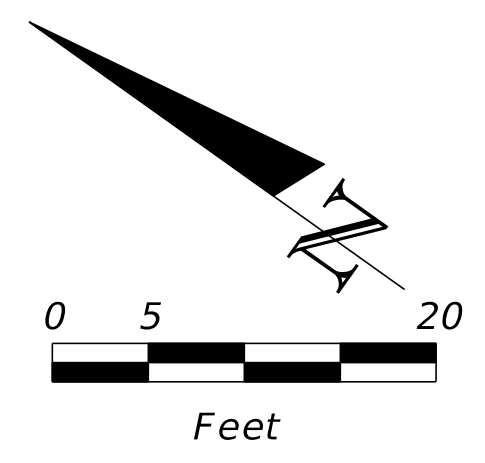

REVISIONS			
DATE	DESCRIPTION	DATE	DESCRIPTION

ROBERT P. BISHOP, JR., P.E.
 P.E. LICENSE NUMBER 38546
 NORTH FLORIDA PROFESSIONAL SERVICES
 PO BOX 3823
 LAKE CITY, FLORIDA 32056
 CERTIFICATE OF AUTHORIZATION 29011

BAKER COUNTY BOCC	
PROJECT	NFPS PROJECT NUMBER
SANDERSON FIRE RESCUE STATION	L201005BCC

UTILITY PLAN	SHEET NO.
	C-7